

SUCF PROJECT NO. 29393
CRITICAL MAINTENANCE
EXTERIOR ENVELOPE
VISUAL ARTS #58

CAMPUS
PURCHASE COLLEGE
STATE UNIVERSITY OF NEW YORK
735 ANDERSON HILL ROAD
PURCHASE, NY 10577

CLIENT
STATE UNIVERSITY CONSTRUCTION FUND
353 BROADWAY
ALBANY, NY 12246
518.689.2605

ARCHITECT
ROBERT SIEGEL ARCHITECTS
37 WEST 37th STREET, 12th FLOOR
NEW YORK, NY 10018
212.921.8400
www.robertsiegelarchitects.com

LIGHTING & ELECTRICAL
WHITEHOUSE LIGHTING DESIGN
4 TENNIS COURT ROAD
MAHOPAC, NY 10541
914.923.0021

ENVIRONMENTAL
ADELAIDE ENVIRONMENTAL HEALTH ASSOCIATES
1511 ROUTE 22 SUITE C24
BREWSTER, NY 10509
845.278.7710


STRUCTURAL
ANASTOS ENGINEERING ASSOCIATES
240 W 35th STREET ROOM 301
NEW YORK, NY 10001
212.714.0993

MECHANICAL
M.A. RUBIANO, P.C.
64 FULTON STREET SUIT 505
NEW YORK, NY 10038
212.732.7842

LANDSCAPE
DLANDSTUDIO LLC
137 CLINTON STREET
BROOKLYN, NY 11201
718.624.0244

- NOTES:**
- SEE SHEETS A-503 FOR EXTERIOR SOFFIT DETAILS
 - SEE A-602 FOR INTERIOR CEILING DETAILS
 - FOR LIGHTING FIXTURE TYPE WF1 LAYOUT, REFER TO 1/601
 - PREPARE, PRIME AND PAINT ENTIRE GWB CEILING AT ROOM 0005

- LEGEND:**
- 092900 GB03
 - 092900 GB03 - HIGH
 - 092400 STUCCO
 - 084413 ALUMINUM PANEL
 - EXISTING ACOUSTIC CEILING TILE

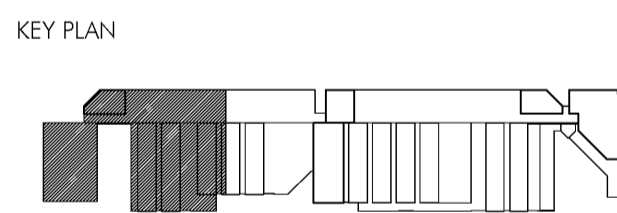

NO.	DATE	REMARKS


PROJECT 0801
DRAWN BY RA
DATE 01.27.2010
SCALE 1/8"=1'-0"

DRAWING TITLE

LEVEL 2
REFLECTED CEILING
PLAN - SOUTH

DRAWING NO.

A-145

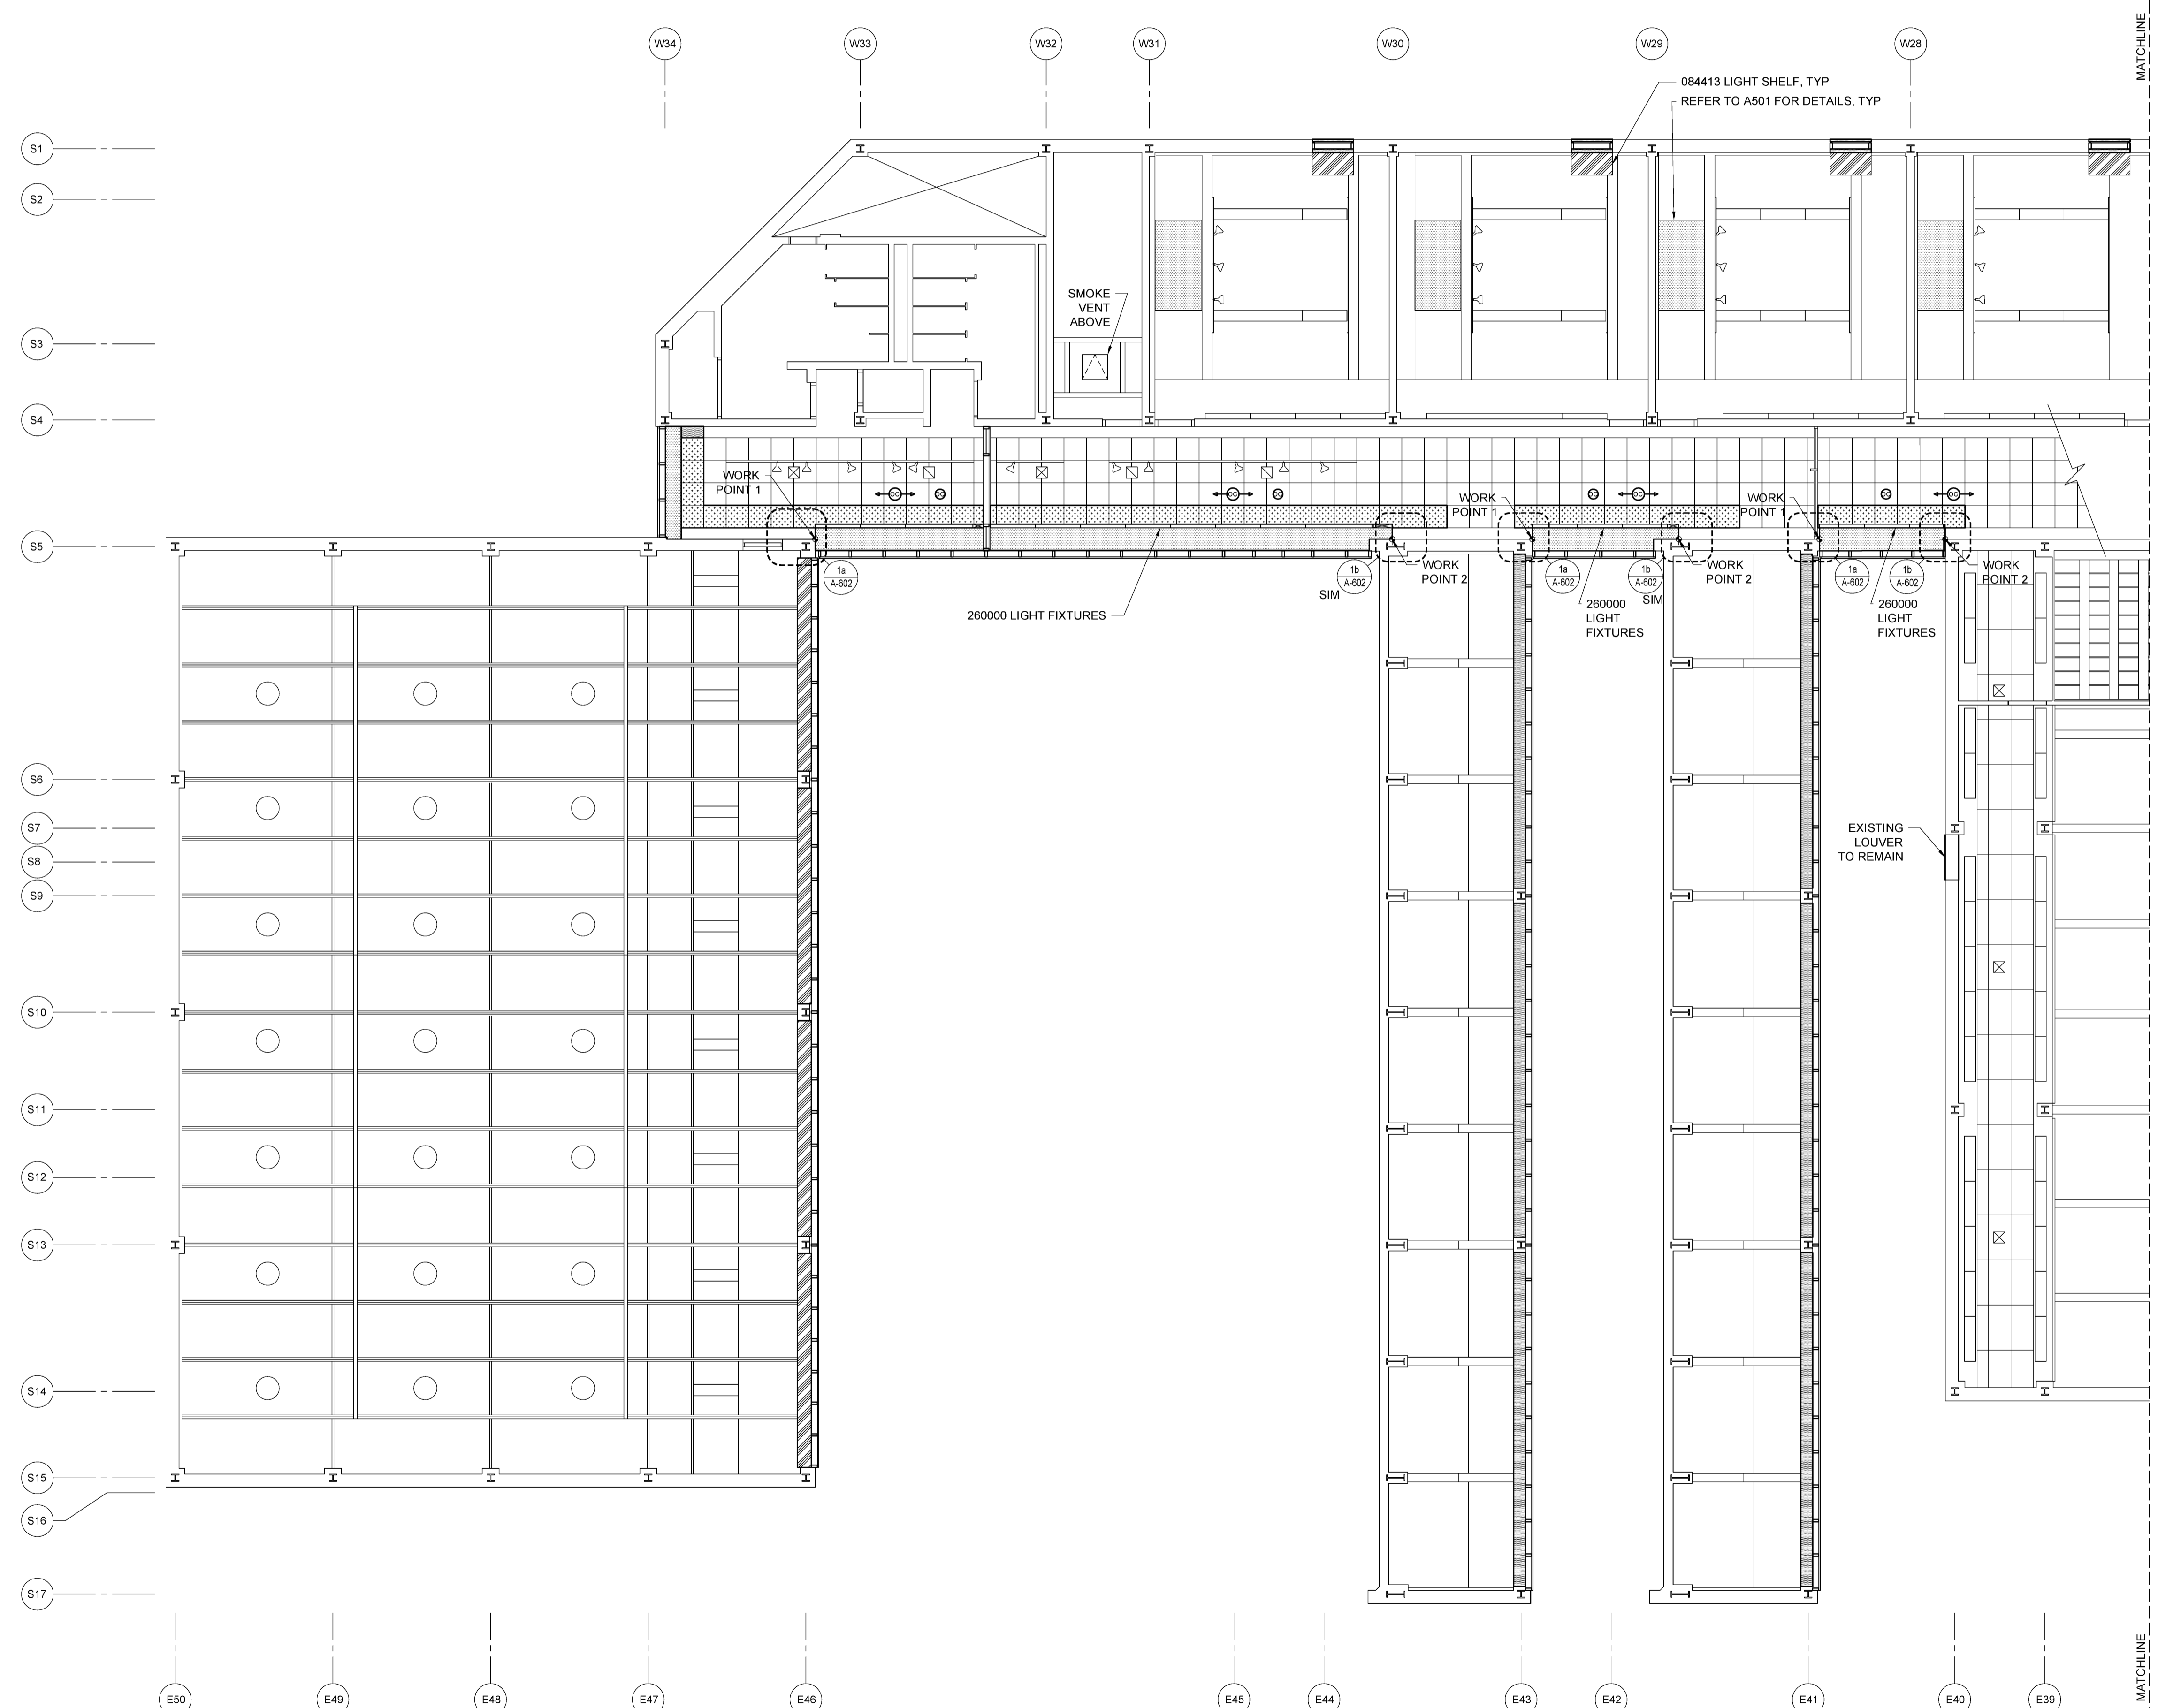

1 LEVEL 2 REFLECTED CEILING PLAN
SCALE: 1/8" = 1'-0"