


- GENERAL NOTES:**
1. INSTALL NEW-FIN TUBE RADIATION CONNECTED TO EXISTING PIPING, SEE DETAIL FOR FITTINGS.
  2. REMOVE EXISTING FIN-TUBE RADIATION AND CONNECTING PIPING TO EXISTING SHUT OFF VALVES. SHUT-OFF ZONE ISOLATING VALVES TO PREVENT LEAKAGE IN CASE OF DAMAGE OF RADIATION SHUT OFF VALVES. INSTALL NEW FIN-TUBE RADIATION CONNECTED TO EXISTING PIPING, USING NEW FITTINGS AS REQUIRED, AFTER NEW WORK OF WINDOW REPLACEMENT IS COMPLETED. SEE DETAIL FOR FITTINGS REQUIRED.

WRITTEN SPECIFICATIONS ARE PART OF THESE DOCUMENTS.

BASEMENT FLOOR PLAN  
 SCALE: 1/8" = 1'-0"

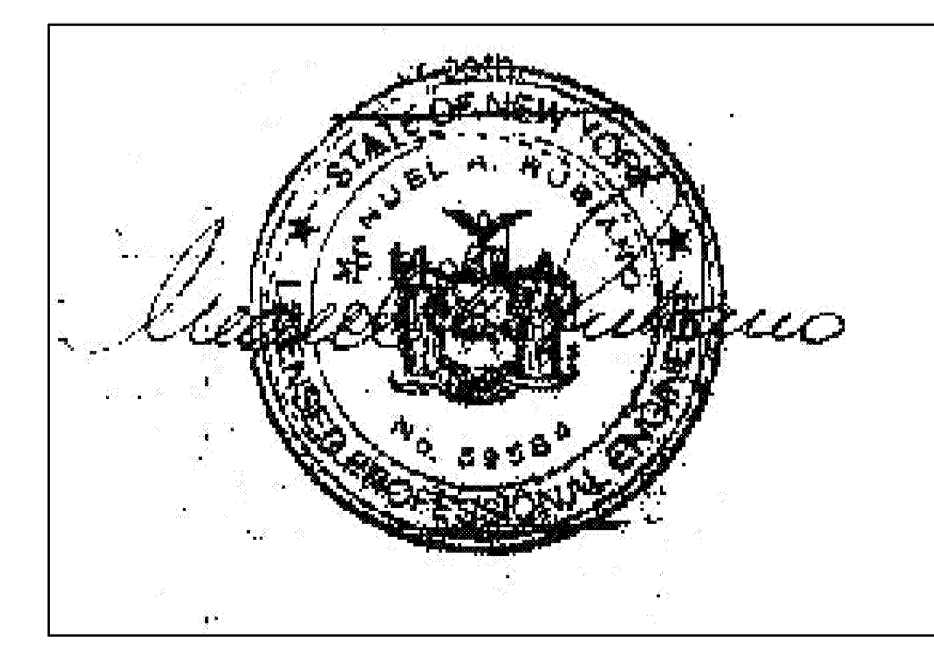

PROJECT 0801  
 DRAWN BY RFB  
 DATE 1.27.2010  
 SCALE 1/8"=1'-0"  
 DRAWING TITLE  
 LEVEL 0  
 PLAN - NORTH

DRAWING NO.  
 M-101

